
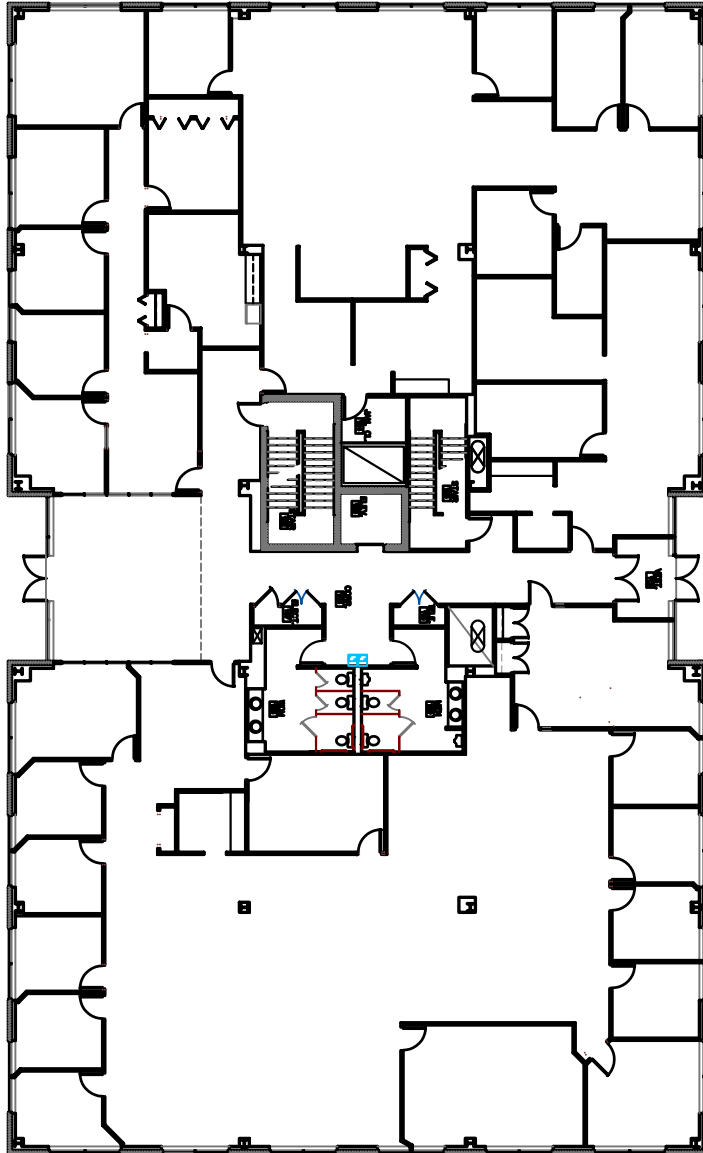


LOWER LEVEL FLOOR PLAN
SCALE = 1/8" = 1'

MECHANICAL FLOOR PLAN = 10/22/04

LOWER LEVEL FLOOR PLAN	<p>  BUILDER / DEVELOPER 1800 CORPORATE CENTER PKY. P.O. BOX 2018 AKRON, OHIO 44308 PHONE: 330-499-3200 FAX: 330-499-3204 </p>	<p> INTERLAKE CORPORATE CENTER 1 4199 KINROSS LAKES PKWY RICHFIELD, OHIO </p>	<p> 11/15/05 11/15/05 </p>
A1	<p> designed by 0-10 1-1-0 drawn by </p>		



FIRST FLOOR PLAN
1/8" = 1'

SEE OTHER FLOOR PLANS - 2004.00

7/20/2004

INTERLAKE CORPORATE CENTER 1
4199 KINROSS LAKES PKWY
RICHFIELD, OHIO


CSM INC.
BUILDER / DEVELOPER
1800 CORPORATE SQUARE NW
FALL RIVER, MA 01936
ANNEX, OHIO 43089
202-462-3823

contract no.
date
1-4-04
drawn by

FIRST FLOOR PLAN

A2

SECOND FLOOR PLAN
1/8" = 1'

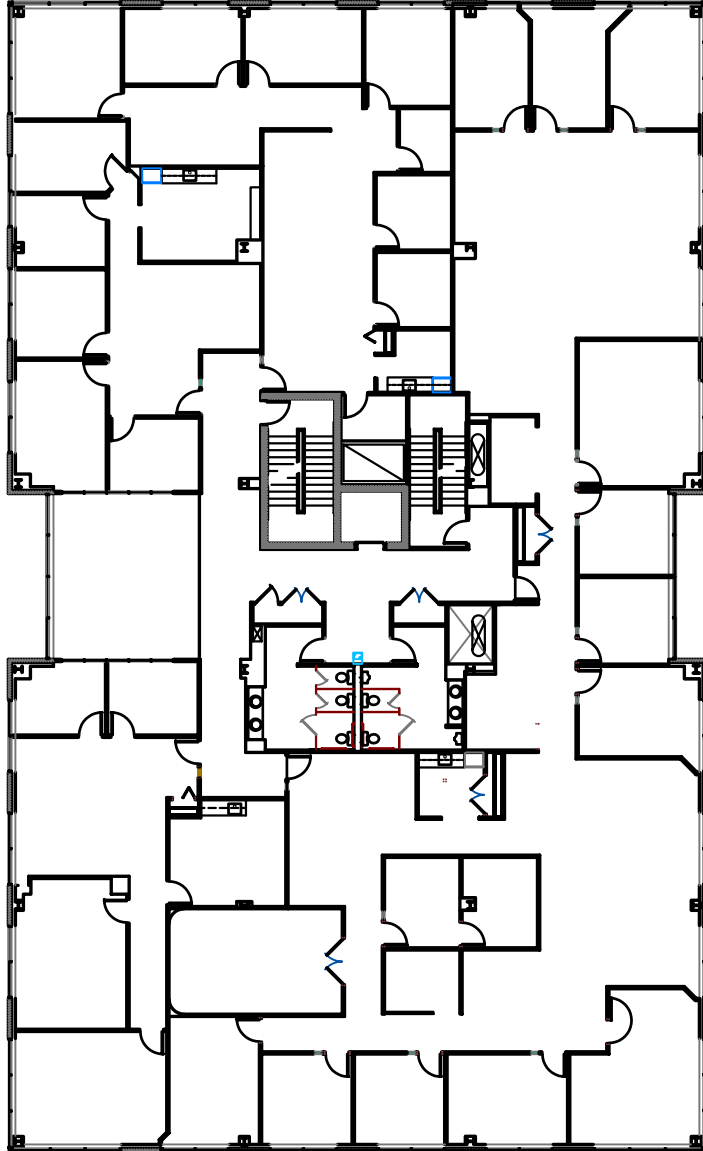

FORMER FLOOR PLAN - 10/20/07

10/20/07

SECOND FLOOR PLAN

A3


Prepared by:
Date:
Drawn by:

CSM INC.
BUILDER / DEVELOPER
1800 CORPORATE CENTER PKY.
AVON, OHIO 44003
200-400-3000

INTERLAKE CORPORATE CENTER 1
4199 KINROSS LAKES PKWY
RICHFIELD, OHIO

THIRD FLOOR PLAN
1/4" = 1' - 0"

PRINTED FROM REV. 01/2014

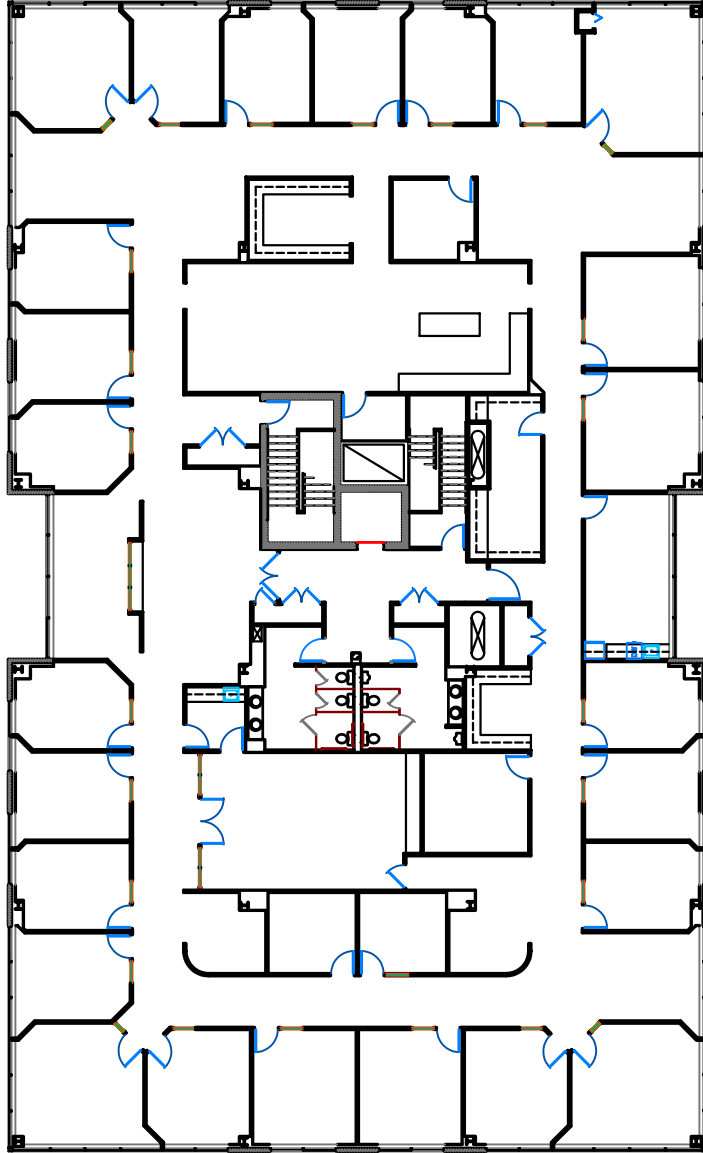

THIRD FLOOR PLAN

A4

continued on
sheet C-30
date 01-14-14
drawn by

CSM
INC.
BUILDER / DEVELOPER
1800 CORPORATE SQUARE NW
A.S. BOX 2018
MARIETTA, OHIO 43026
530-400-3000

INTERLAKE CORPORATE CENTER 1
4199 KINROSS LAKES PKWY
RICHFIELD, OHIO

revisions